
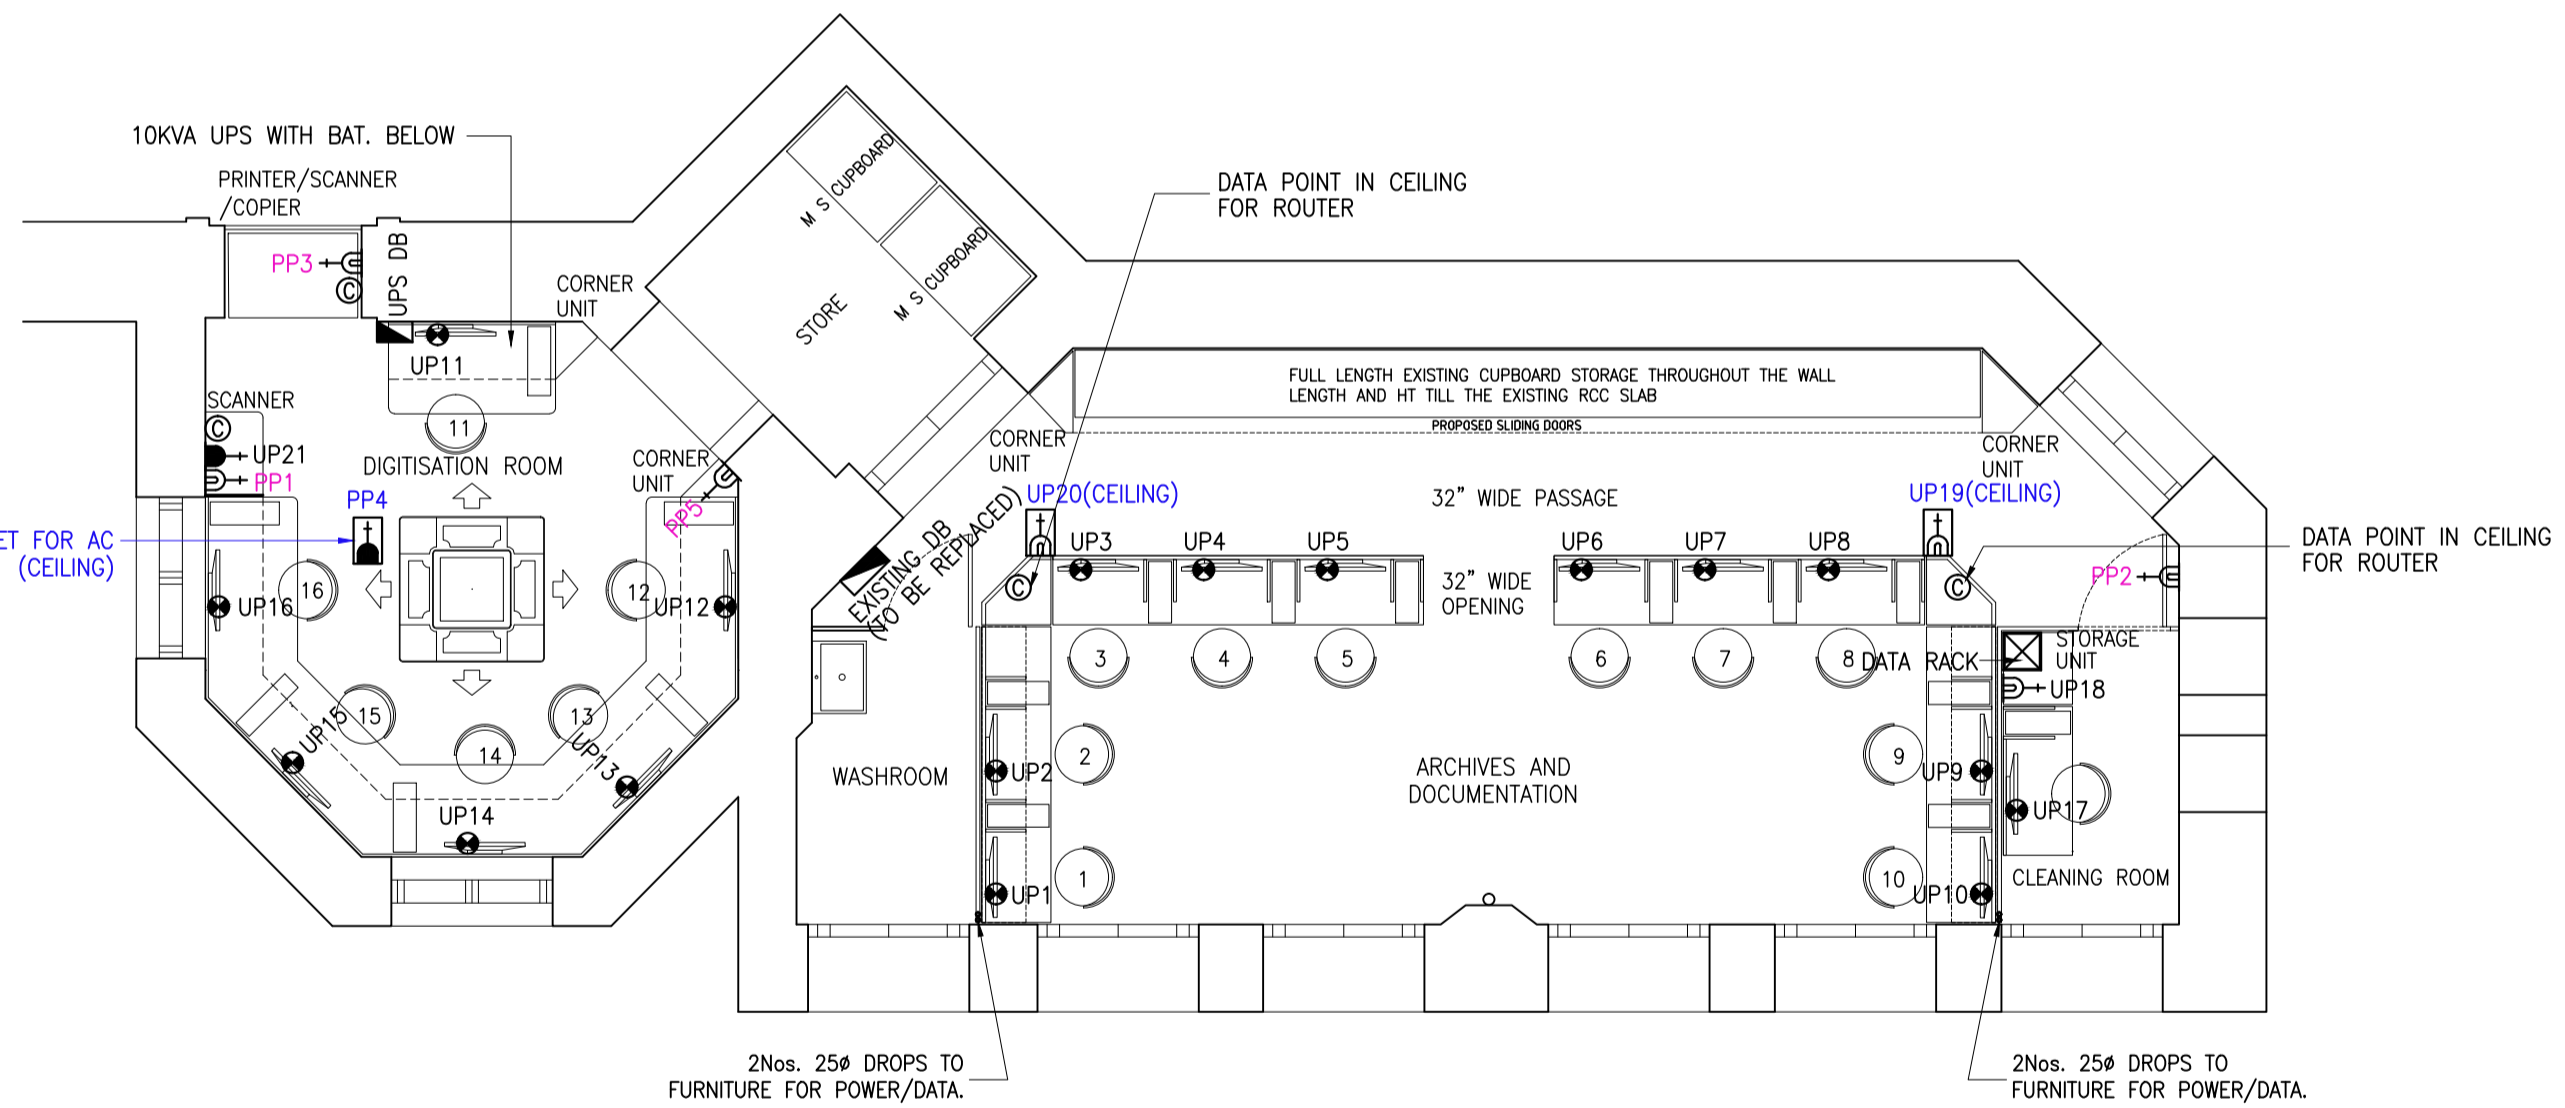


LIGHTING LAYOUT

ARCHIVES DB


CONN. LOAD : 12.50 KW

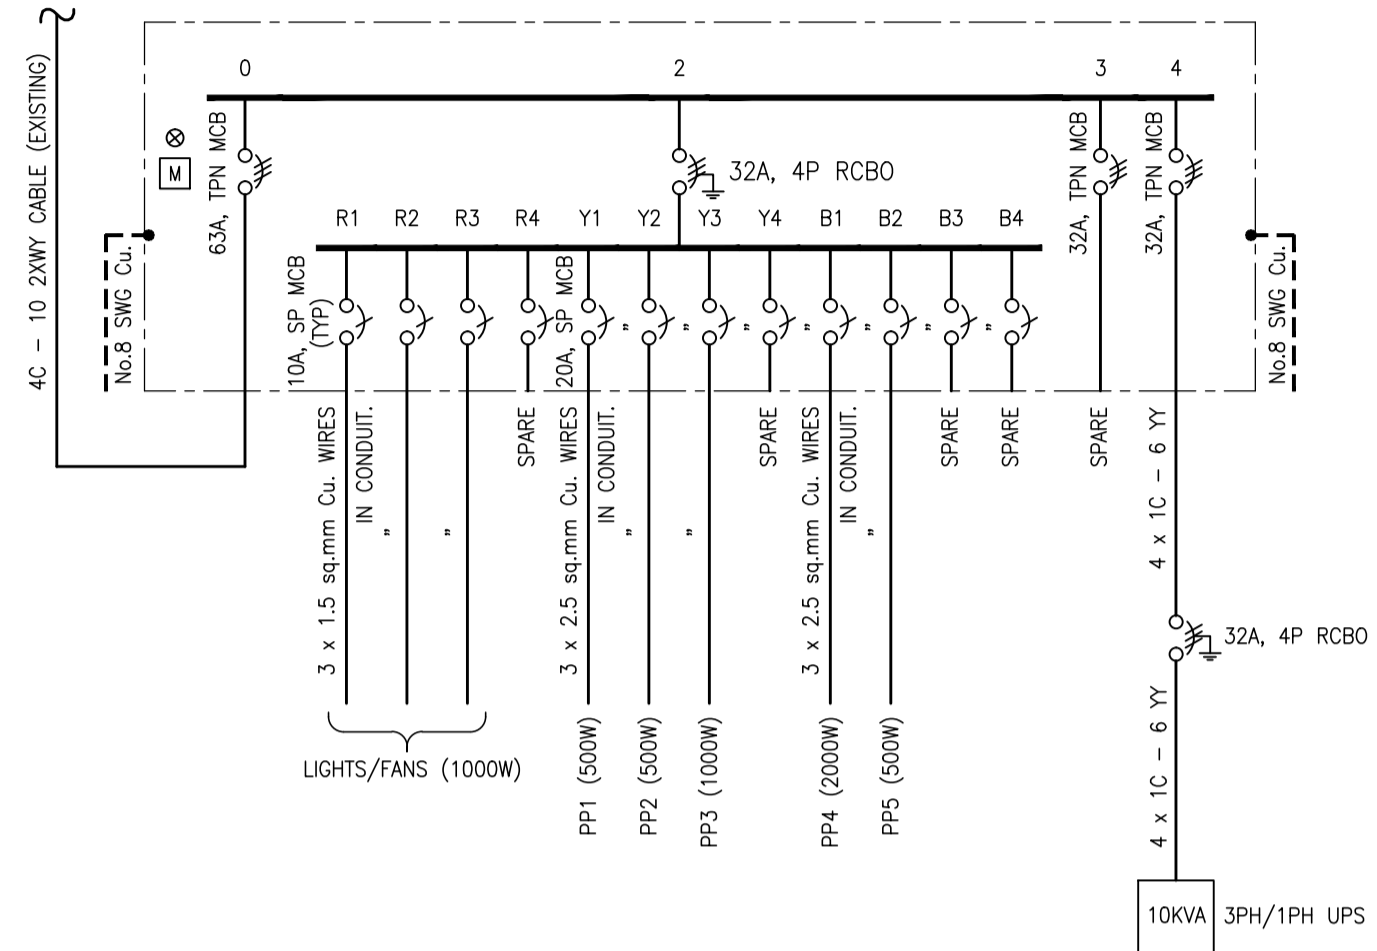

POWER & ELV LAYOUT

UDB

8 WAY SPN
CONN. LOAD : 7.00 KW

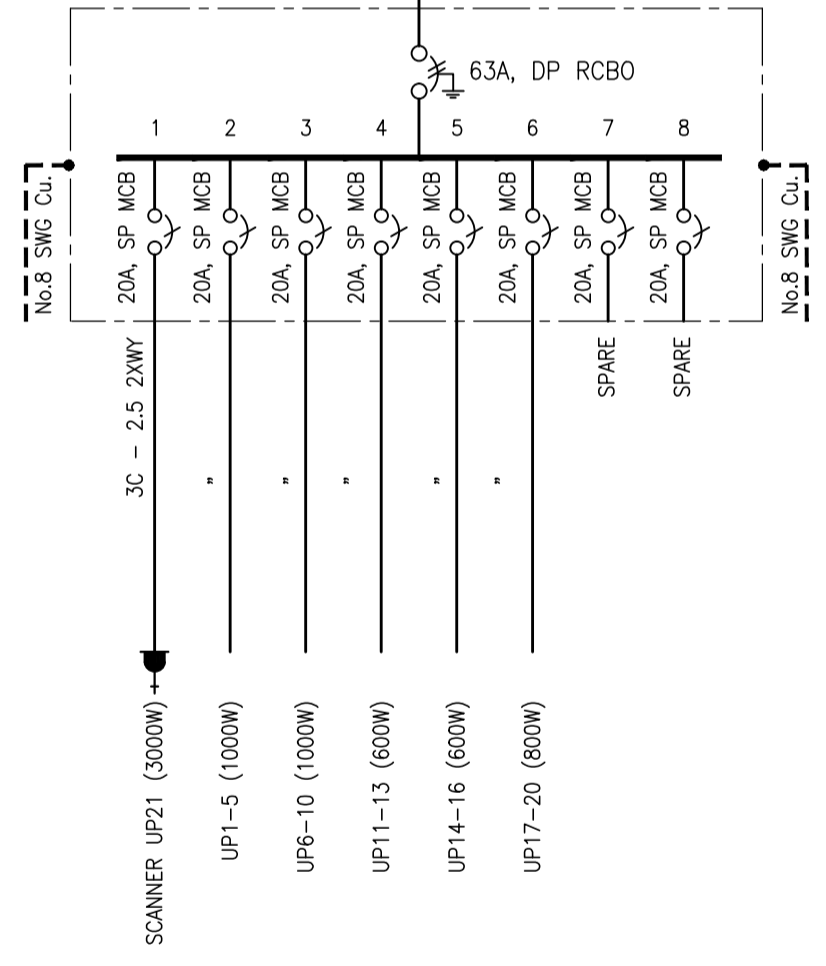

LEGEND

SYMBOL	DESCRIPTION
	40W, 1200mm LED SUSPENDED LIGHT FITTING (<12 UGR)
	40W, 1200mm LED SUSPENDED LIGHT FITTING (DIMMABLE)
	12W, SURFACE MOUNTED LIGHT FITTING, (CIRCULAR)
	1200mm SWEEP CEILING FAN, BLDC
	6A, ONE WAY SWITCH.
	FAN REGULATOR WITH SWITCH.
	1No. DATA + 1No. VOICE +2Nos. 6A, SOCKETS BELOW TABLE WITH 1No.16A, SWITCH AND 1No. 6A, SWITCH SOCKET ABOVE TABLE TOP.
	6A, SOCKET OUTLET WITH SWITCH.
	6/16A, SOCKET OUTLET WITH SWITCH.
	DATA OUTLET.
	DISTRIBUTION BOARD.
	SMOKE DETECTOR.
	305mm Ø WALL MOUNTED FAN
	DIMMER KEY PAD
	20A, MODULAR SOCKET WITH ON / OFF PB SWITCH.
	205Ø PVC EXHAUST FAN

NOTES :-

- 1) ALL WIRING FROM EXISTING DB IN CASING & CAPPING.
- 2) LIGHTING / FAN WITH 3 x 1.5 sq.mm & 16A, SOCKET & TWIN 6A, SOCKET WITH 3C x 2.5 sq.mm FRLS WIRES.

DRAWING STATUS	APPROVAL	TENDER	EXECUTION	AS BUILT	SIGNATURE
			✓		

rev	date	description	ckd.
A	2022/08/02	REVISED AS PER ARCH. CHANGES	

consultants **designbureau**
 122-123, SAI COMMERCIAL CENTRE, GOVANDI STATION ROAD, DEONAR, MUMBAI - 400 088. TEL : 25507100, 25507101.
 project **CSMVS MAIN BUILDING RENOVATION & UPGRADATION**
 clients **CSMVS, mumbai.**

title **SECOND FLOOR PART PLAN
ARCHIVES OFFICE LAYOUT - ELECTRICAL**

north	drawn	MANOJ Y. WAREKAR	drawing no.	revision
	scale	1 : 50	2406-AO-11	A
	date	2022/07/11		
	checked	KK		

DRG. PART >