
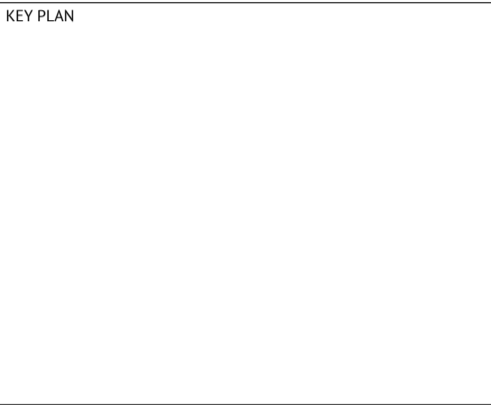


LAYOUT NOTES:
 REFER TO ARCHITECTS DRAWINGS FOR FINAL LIGHTING LAYOUTS
 THIS DRAWING IS TO BE READ IN CONJUNCTION WITH RELEVANT LIGHTING DESIGN PARTNERSHIP DETAIL DRAWINGS, LDP LUMINAIRE AND LIGHTING CONTROL SPECIFICATION AND VERIFIED AGAINST ARCHITECTURAL AND ELECTRICAL ENGINEERING DRAWINGS
 THIS DRAWING IS INDICATIVE ONLY. REFER TO ARCHITECTURAL DRAWINGS FOR FINAL AREAS, LIGHTING LAYOUTS AND QUANTITIES
 REFER ELECTRICAL ENGINEERING DRAWINGS AND SCHEDULES FOR CABLING, CIRCUITING, CONDUIT AND EMERGENCY LIGHTING INFORMATION
 CONTROL CHANNELS SHOWN ARE INDICATIVE OF INTENDED GROUPINGS - REFER TO ELECTRICAL ENGINEERING DRAWINGS FOR FINAL CONTROL INFORMATION

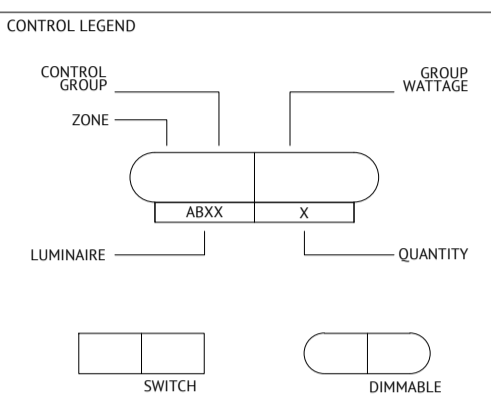

REV	NOTES	DATE
00	ORIGIN	

ARCHITECT & CONSULTANT

CLIENT

LDP
 213-217 Palmer Street
 Darlinghurst NSW 2010
 Australia
 T: +61 2 8353 5383
 F: +61 2 8353 5399
 W: www.LDP.net
 LIGHTING DESIGN PARTNERSHIP Pty Ltd
 ACN 069 070 757

PROJECT
CSMVS MUSEUM


DRAWING STAGE
SCHEMATIC DESIGN

DRAWING
**VASE DISPLAY
 LIGHTING ELEV, PLAN & DETAIL**


DETAILS	SHEET SIZE
LDP_2538_701.DWG PLOTTED BY KAIFENG LI ON 2023-07-07	A1
	REVISION 00

PROJECT & DRAWING NO
LDP_2538_701
 © Lighting Design Partnership Pty Ltd


BASE DRAWING REF:

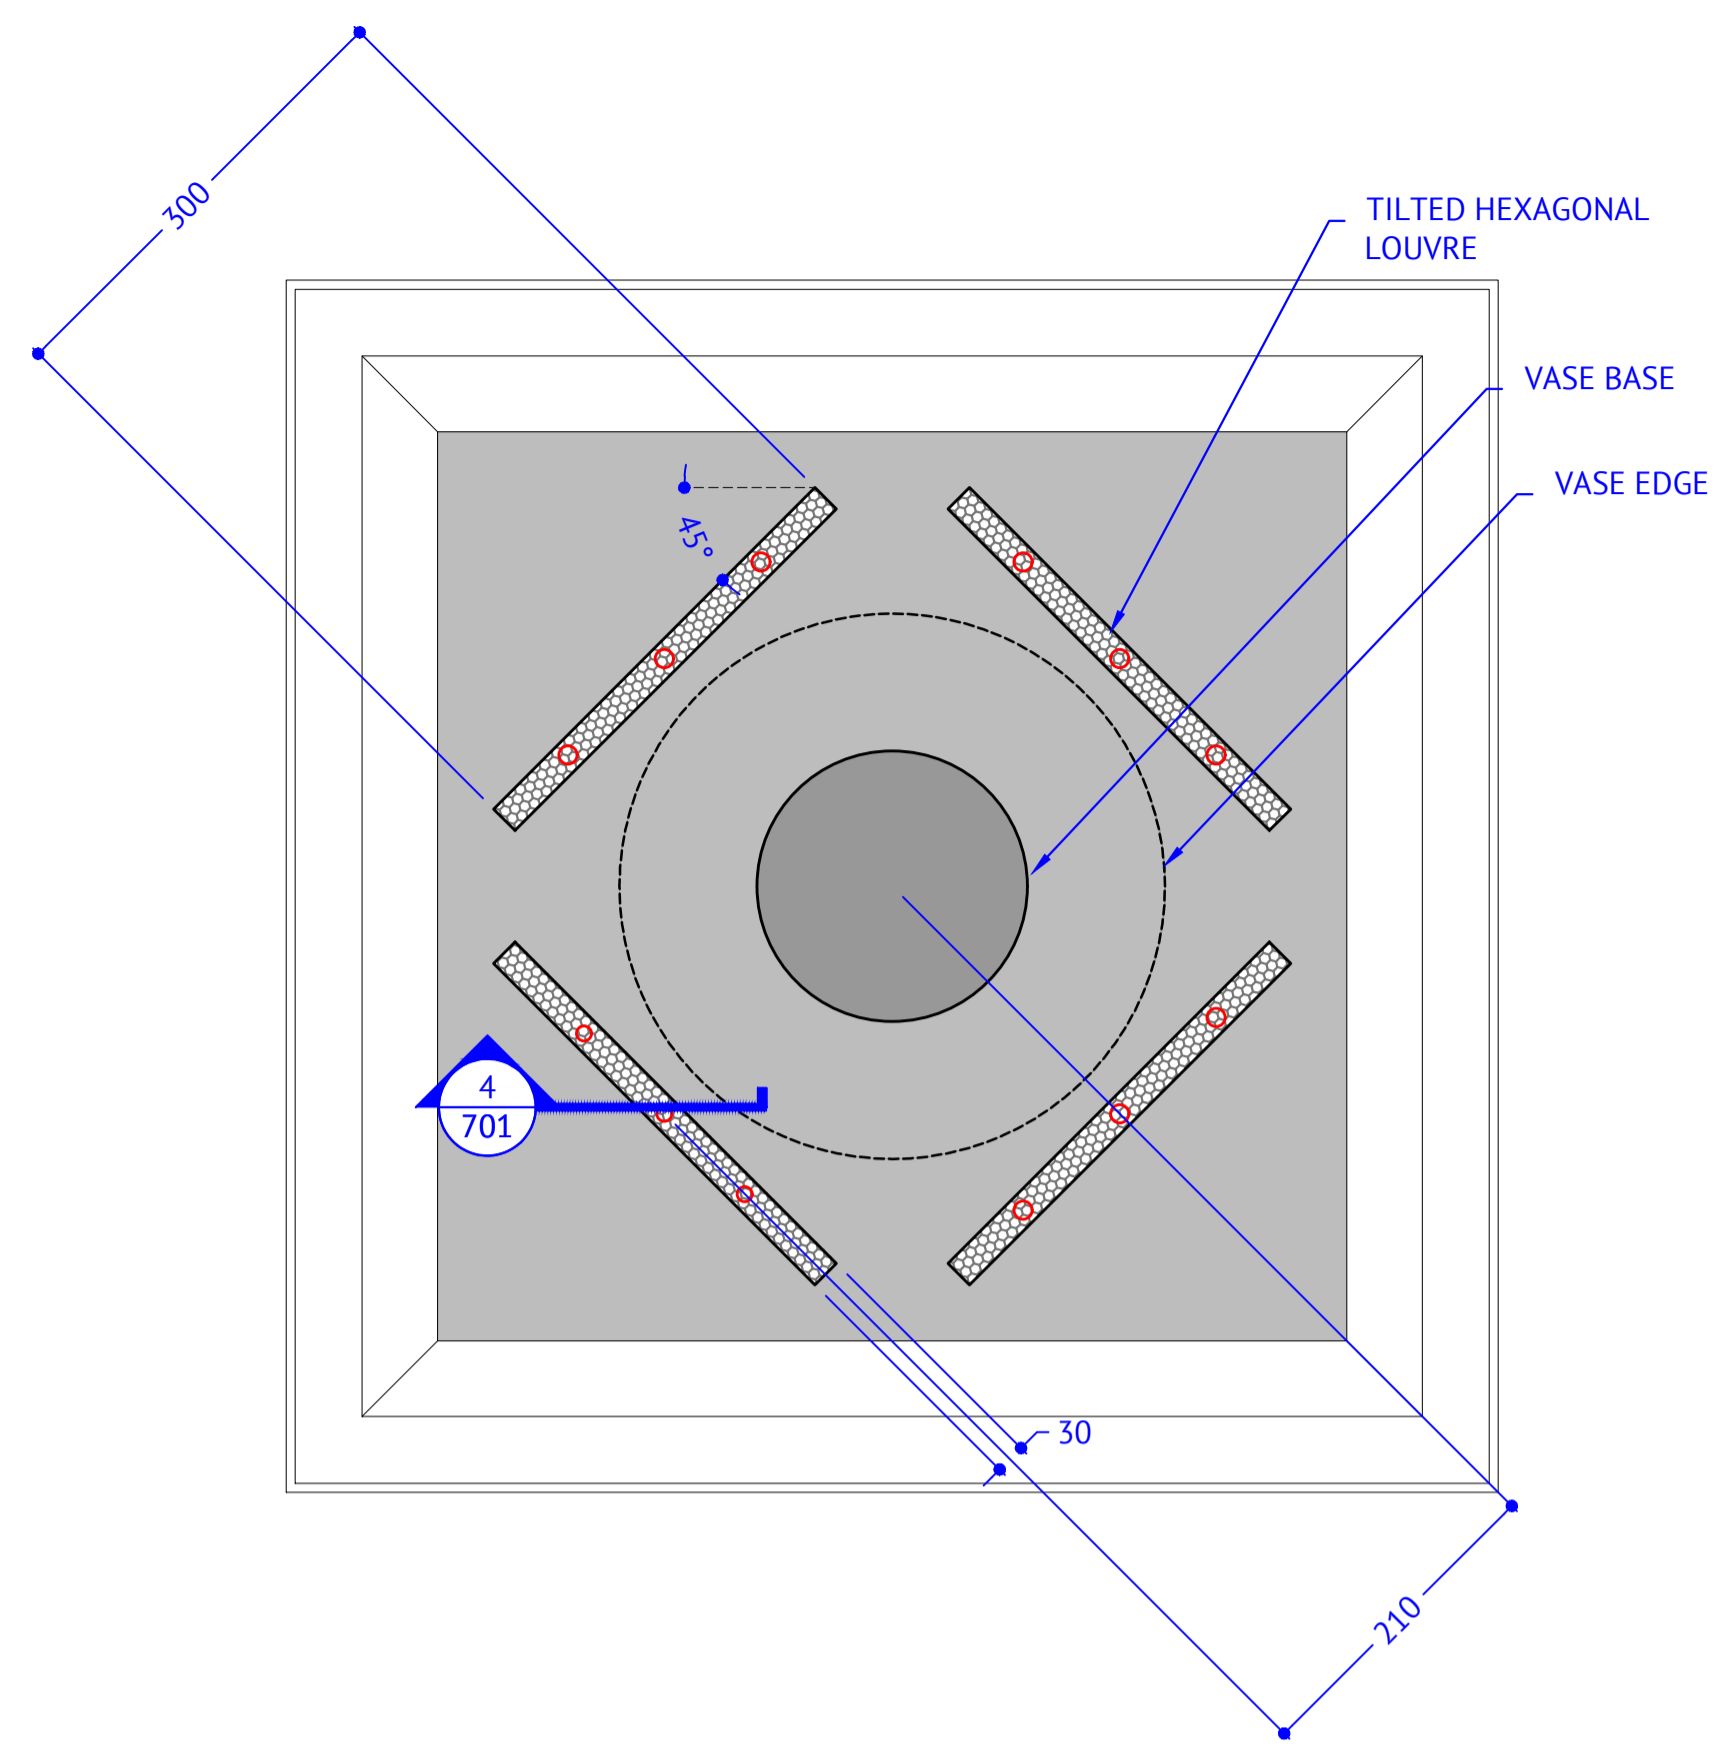


2 PLAN FOR VASE 1
 1:5

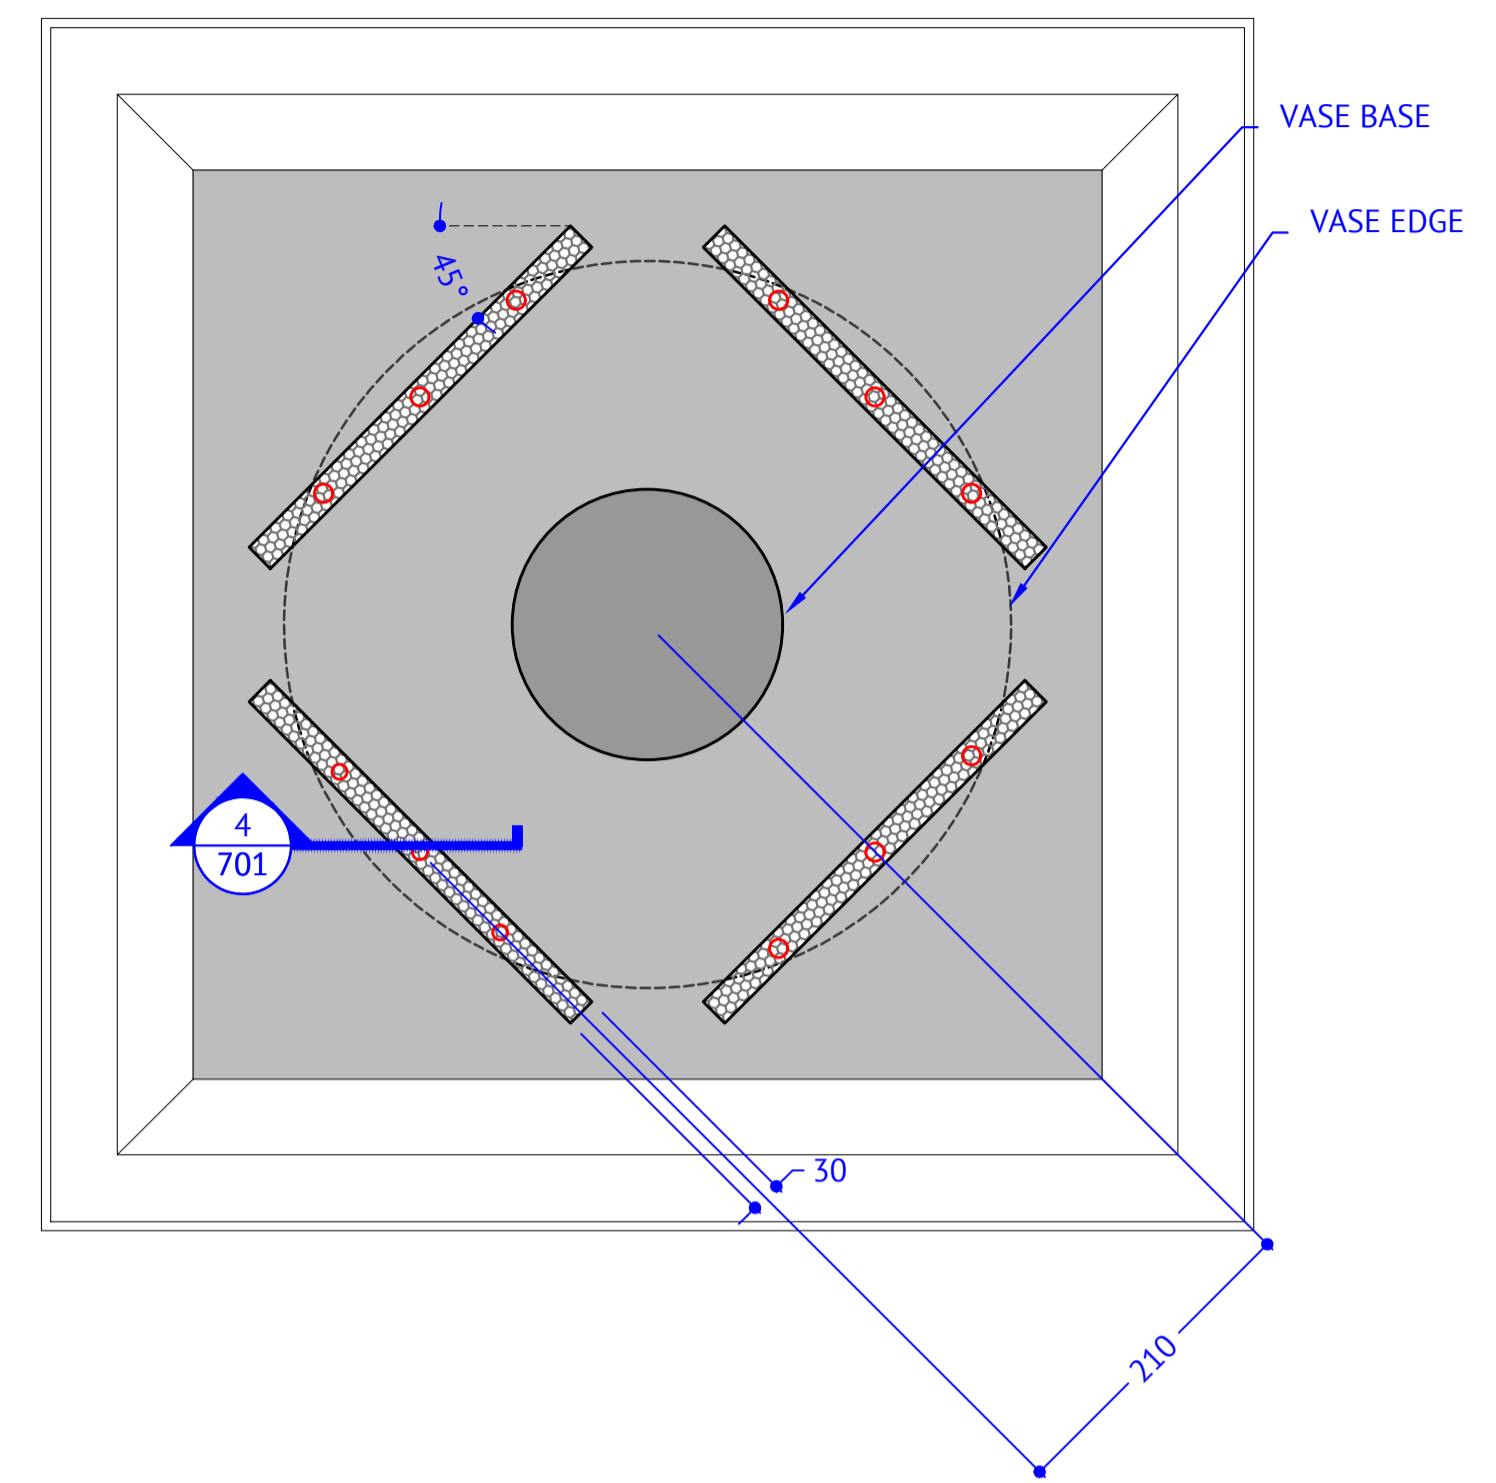

3 PLAN FOR VASE 2
 1:5

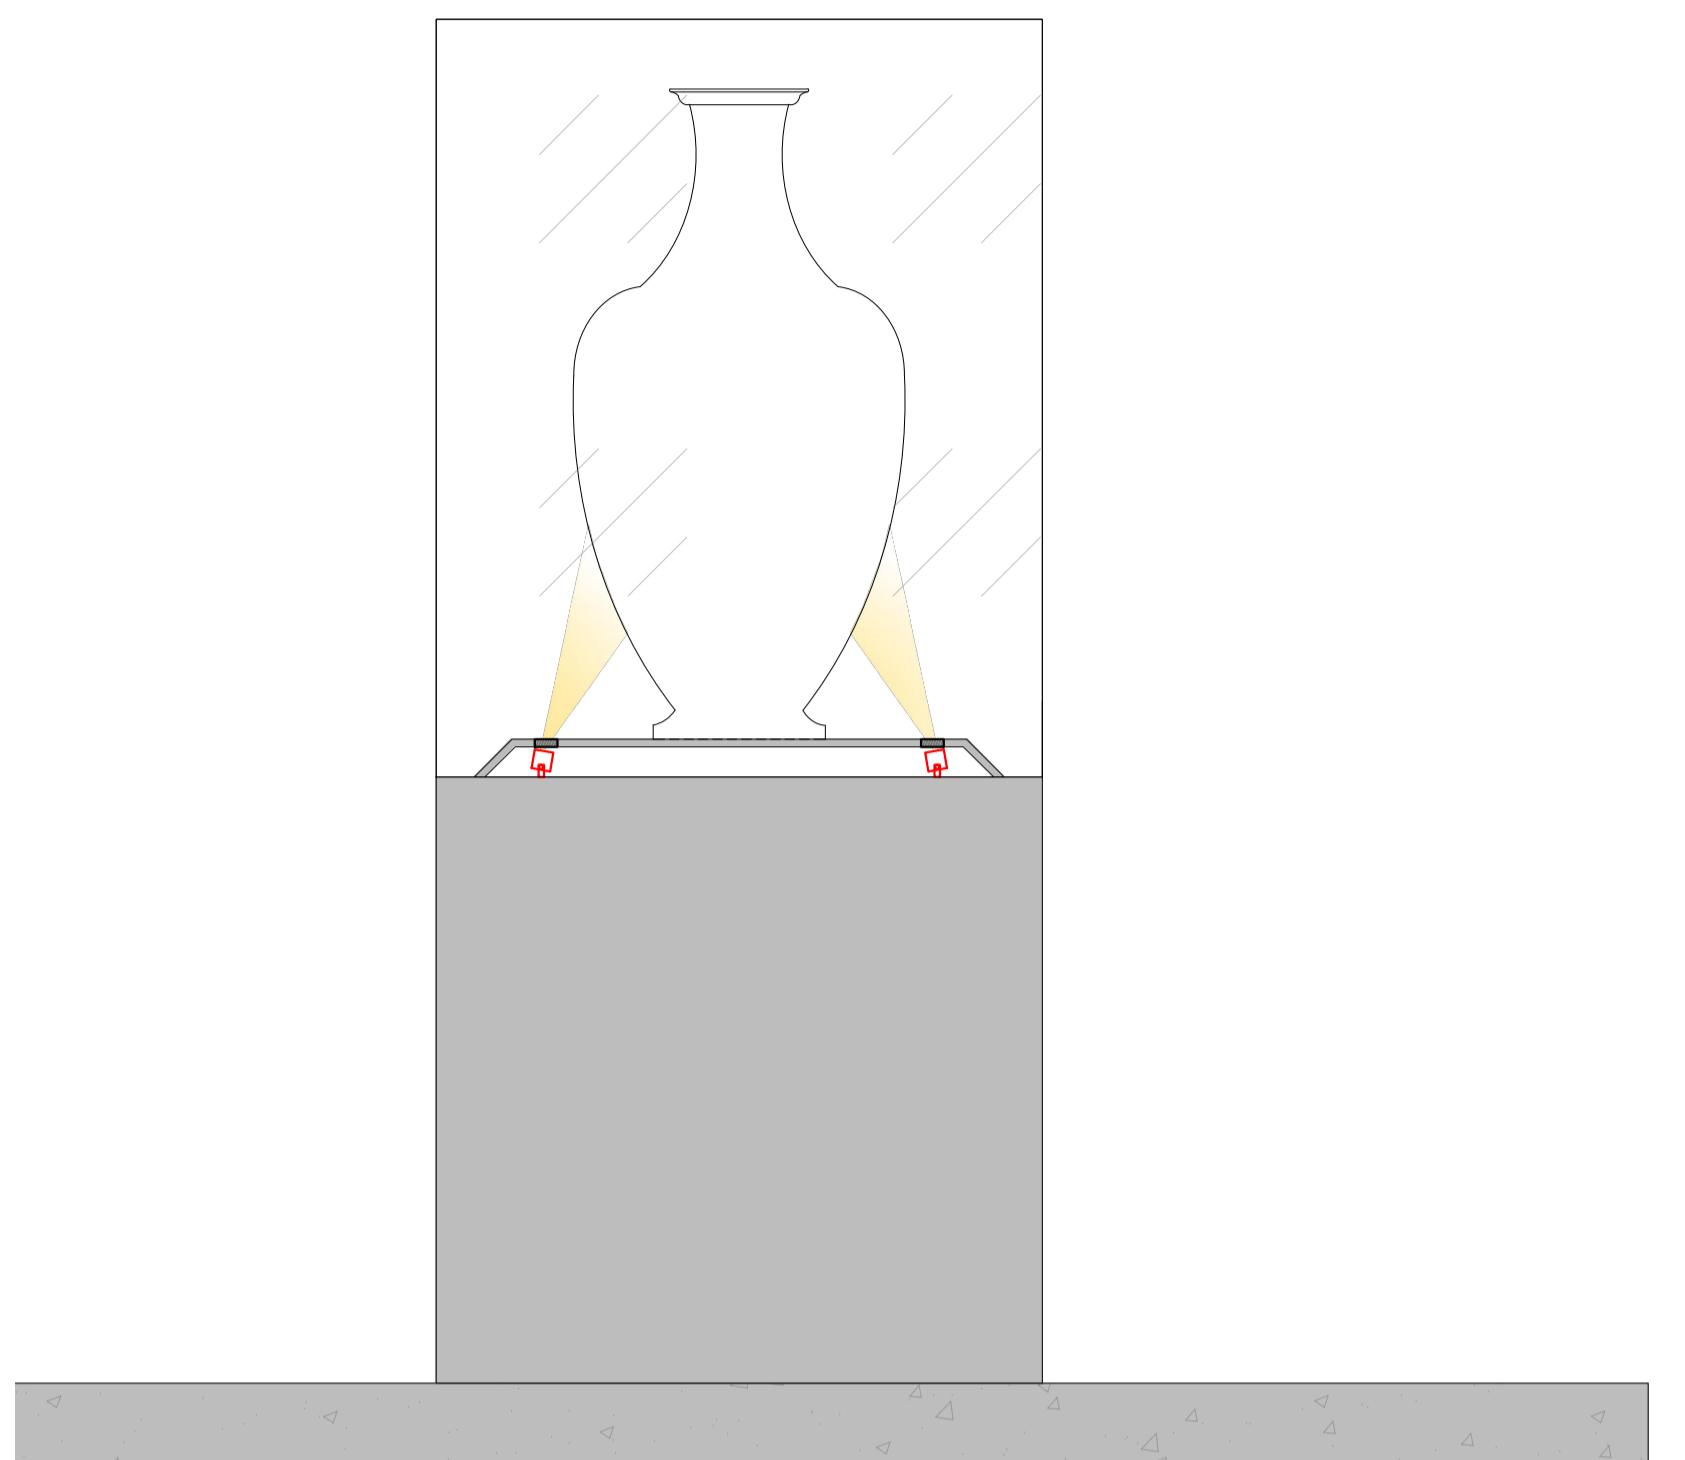

1 INCASE LIGHTING
 1:10

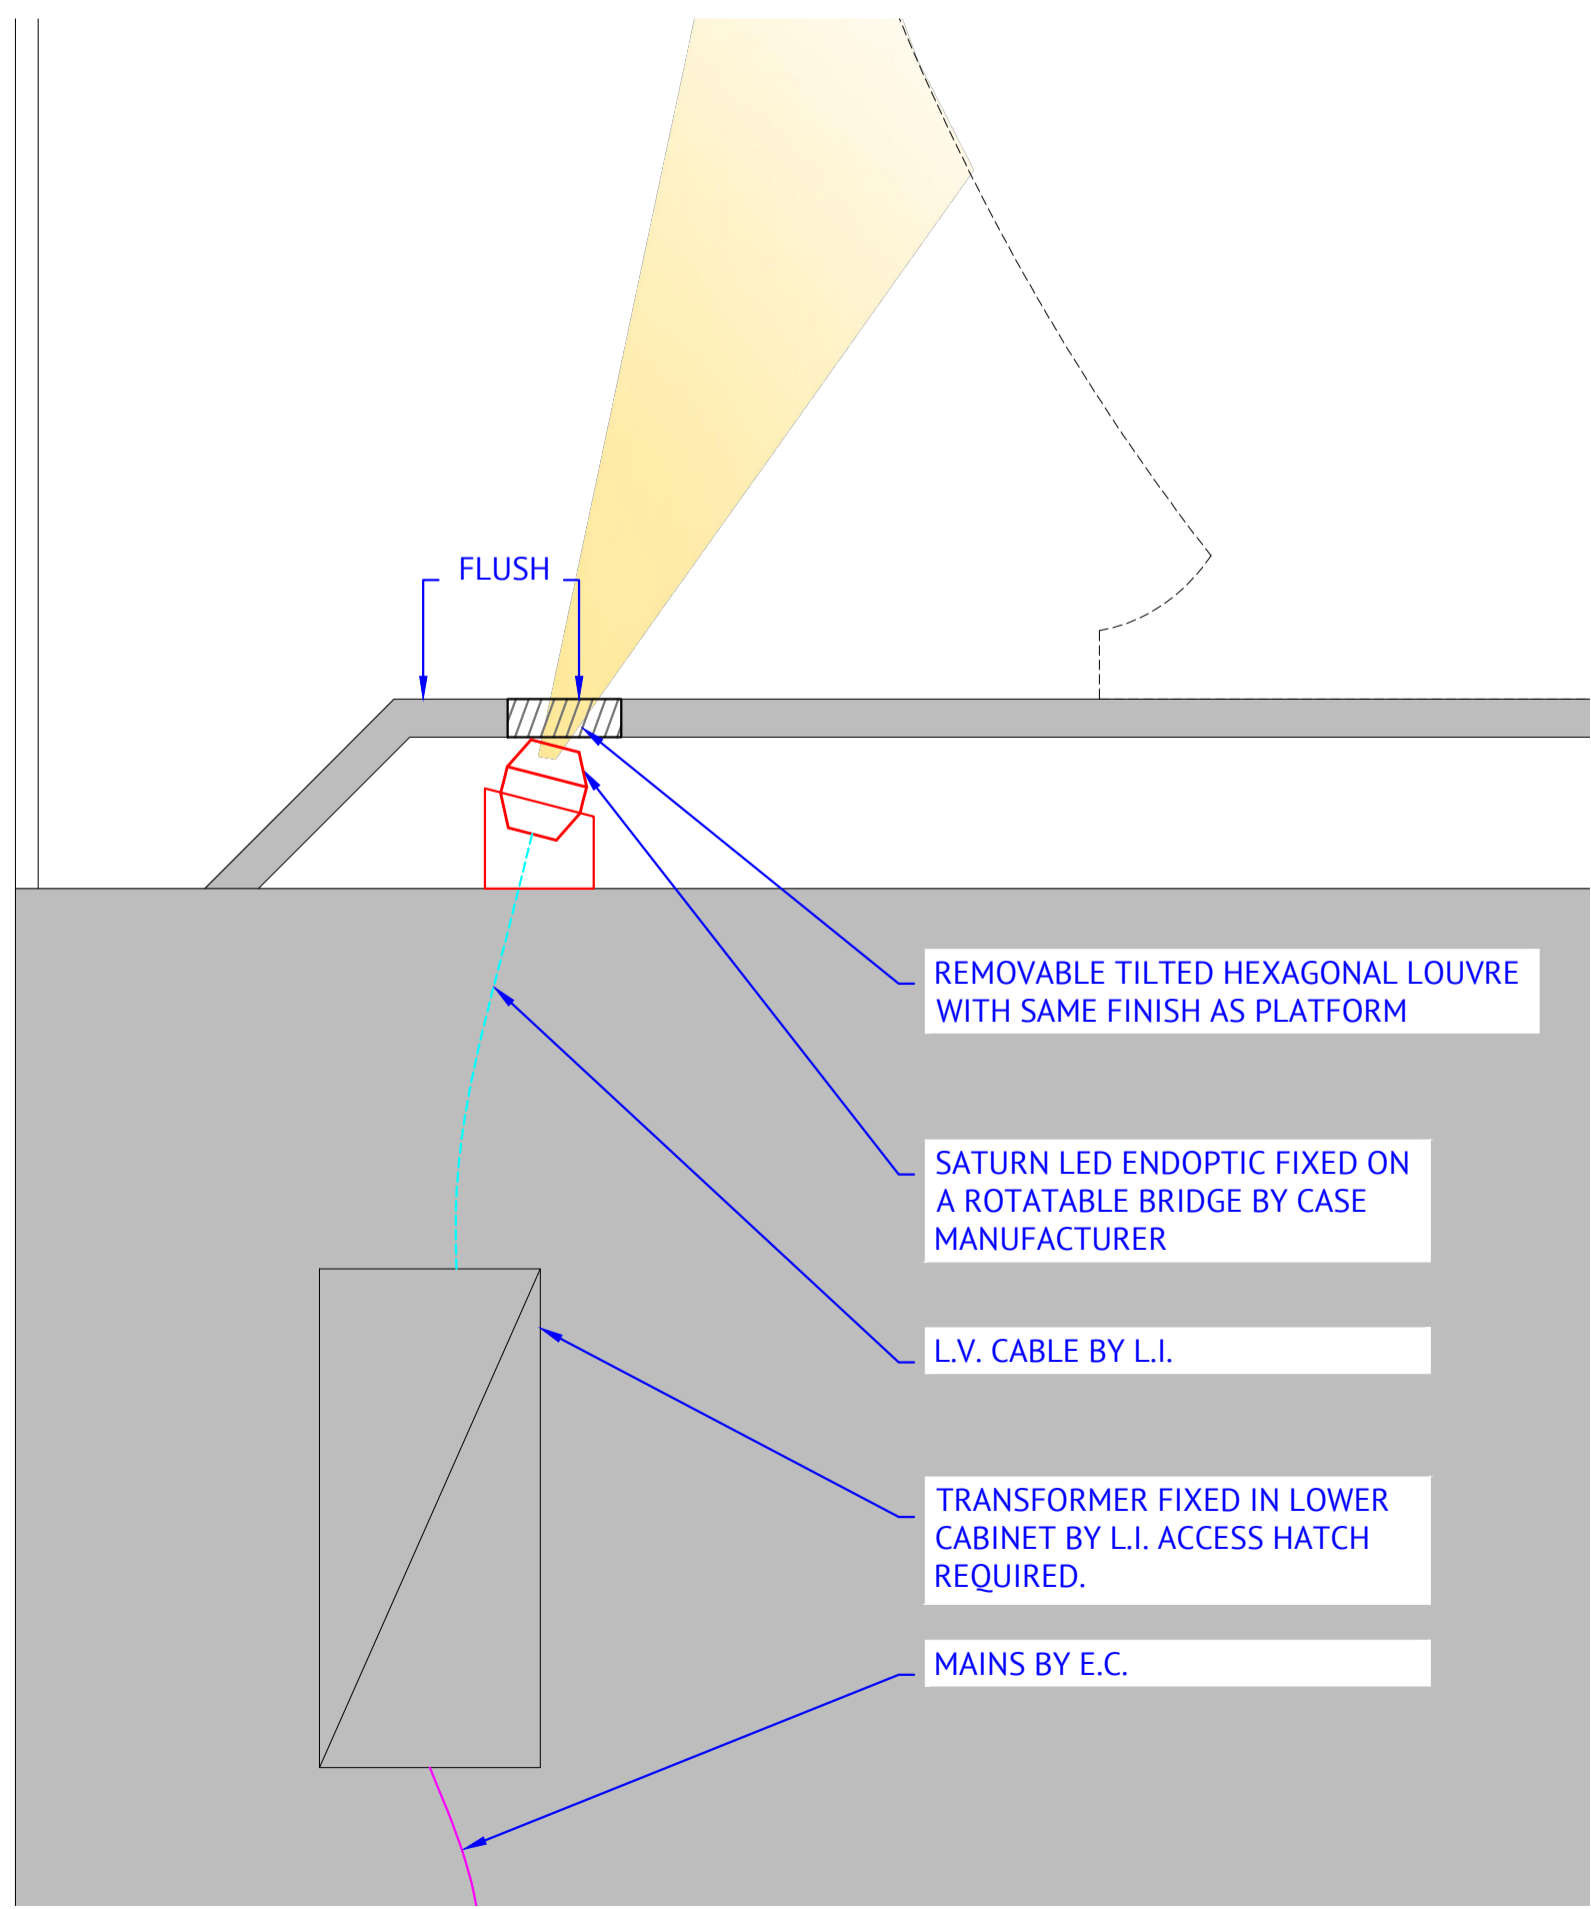

4 SECTION
 1:2

