






NUMBERS REQUIRED: 4  
SCREEN TRANSMITTANCE: 50%

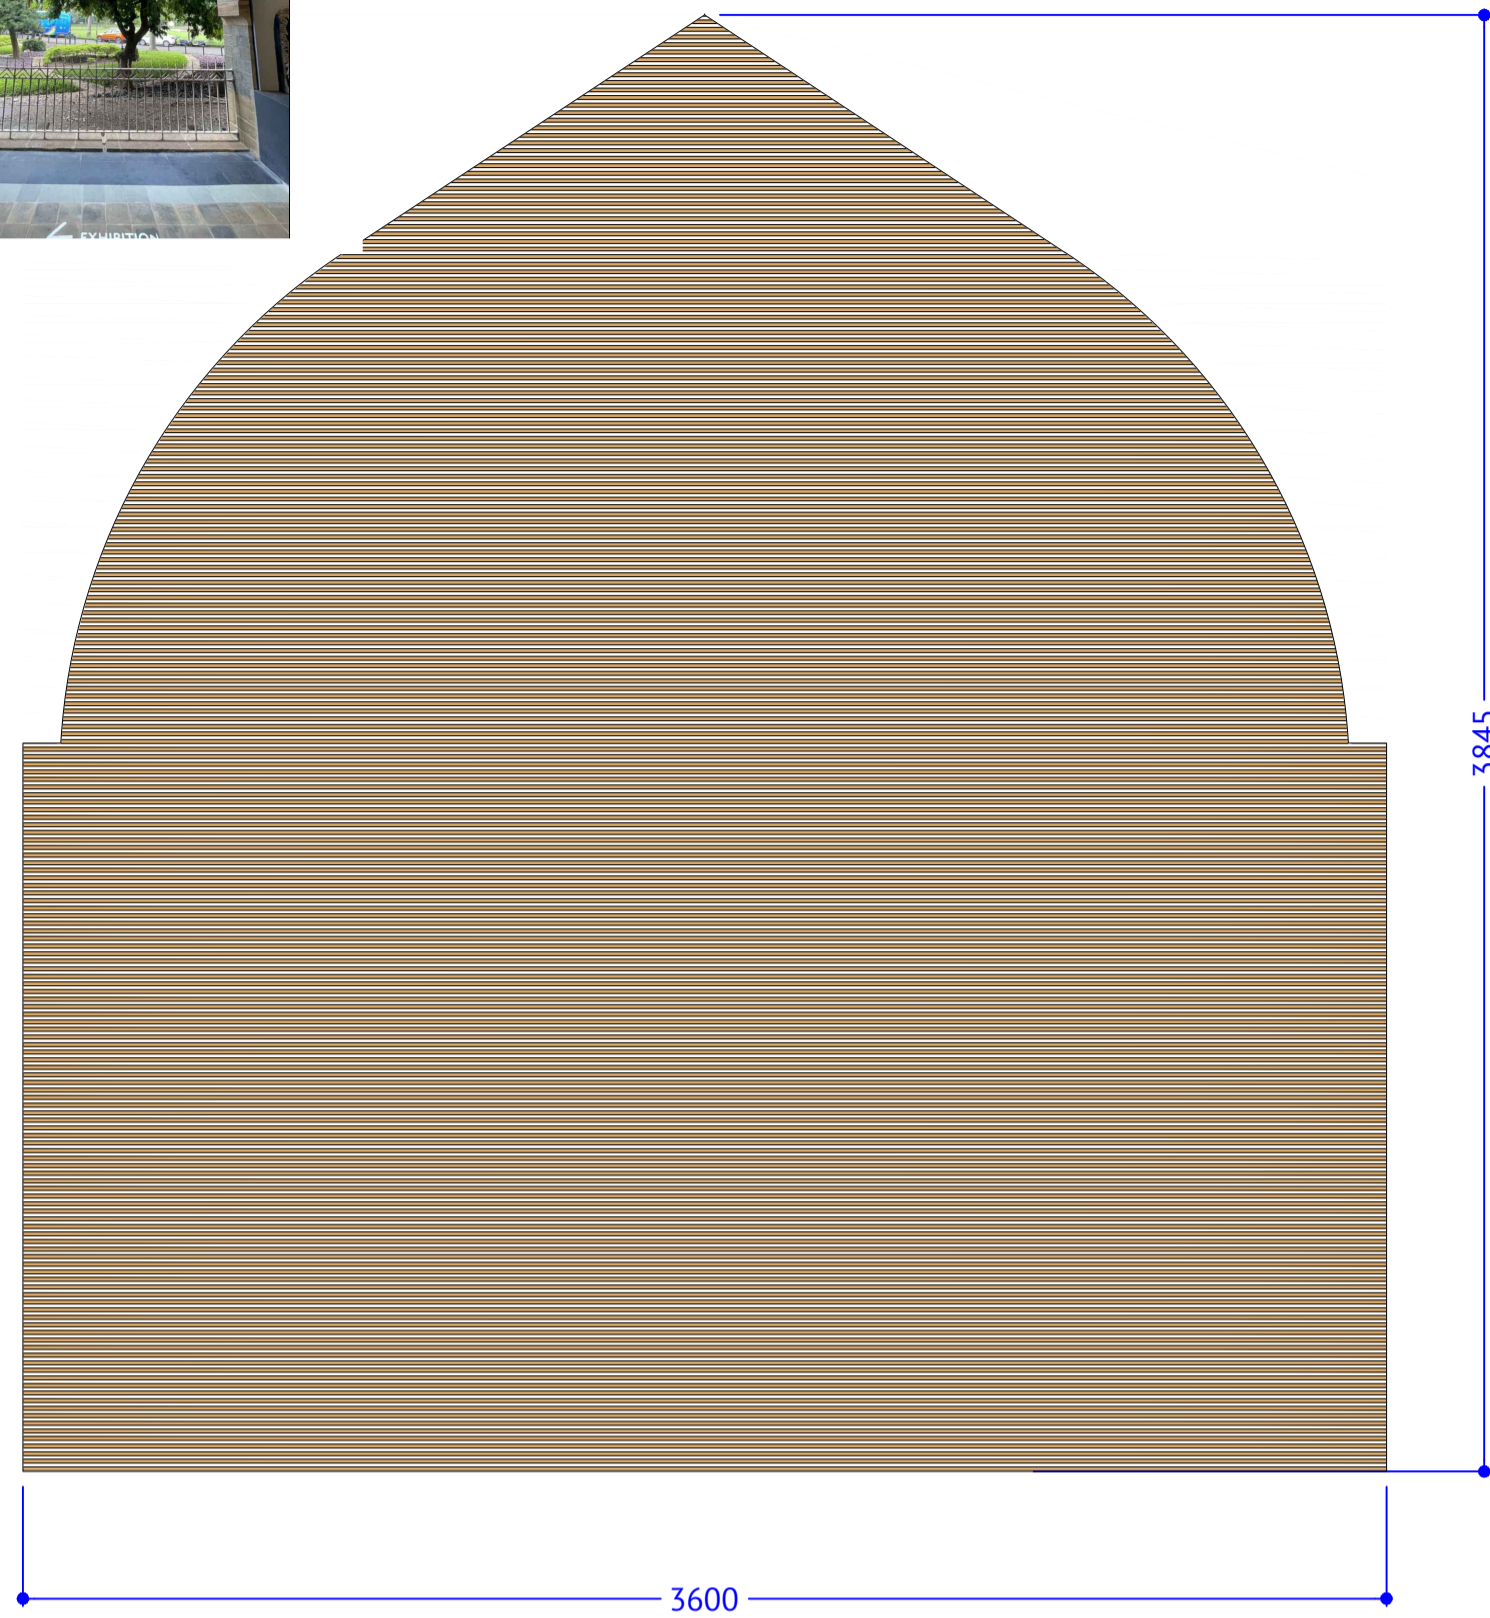


1 GROUND FLOOR CORRIDOR WINDOW ELEVATION  
1:20

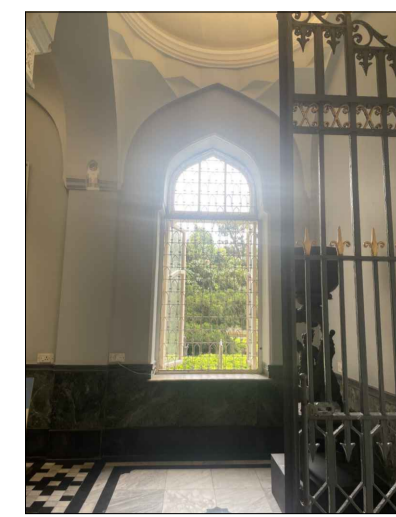


NUMBERS REQUIRED: 1  
SCREEN TRANSMITTANCE: 30%

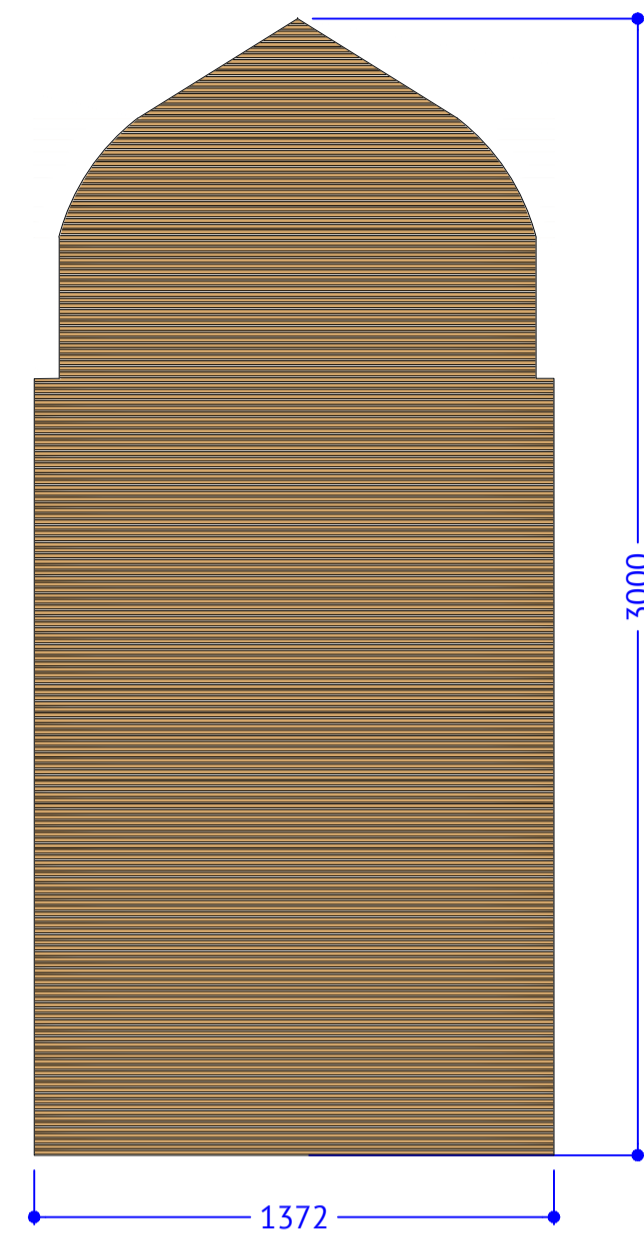



2 GROUND FLOOR FOYER EAST WINDOW ELEVATION  
1:20

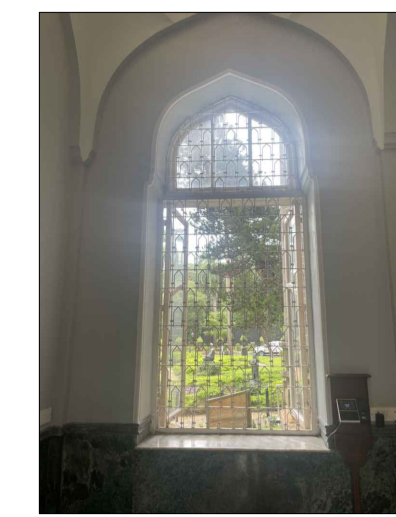


NUMBERS REQUIRED: 1  
SCREEN TRANSMITTANCE: 30%

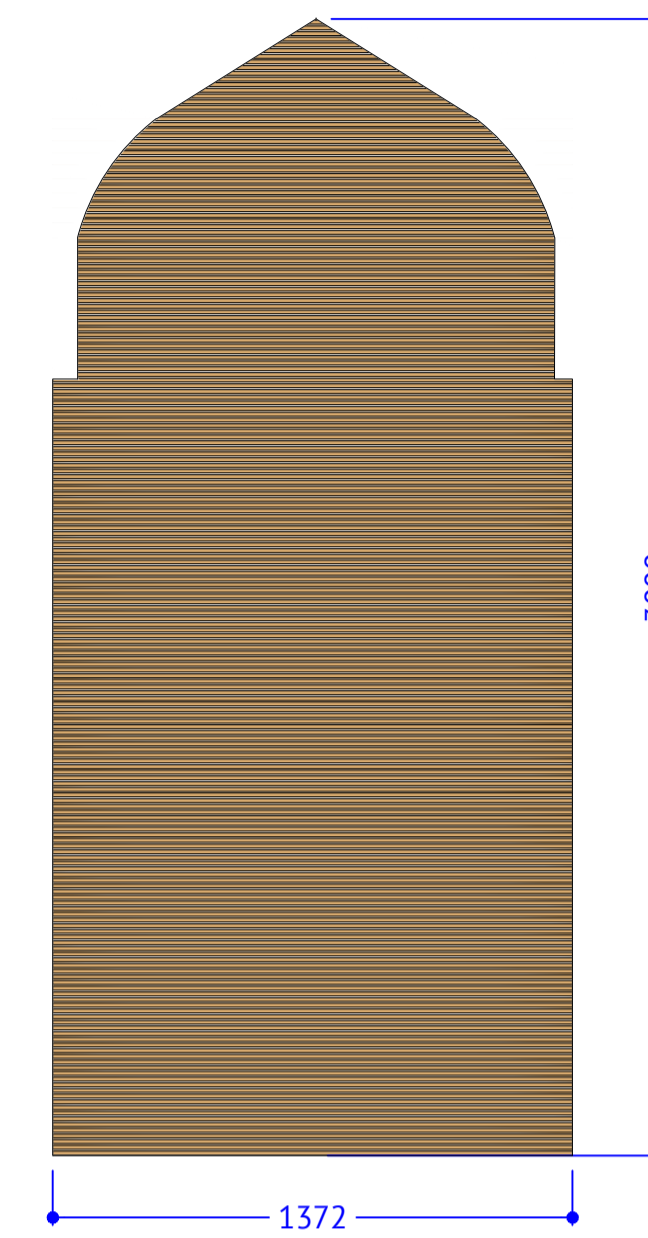


 
3 GROUND FLOOR FOYER WEST WINDOW ELEVATION  
1:20

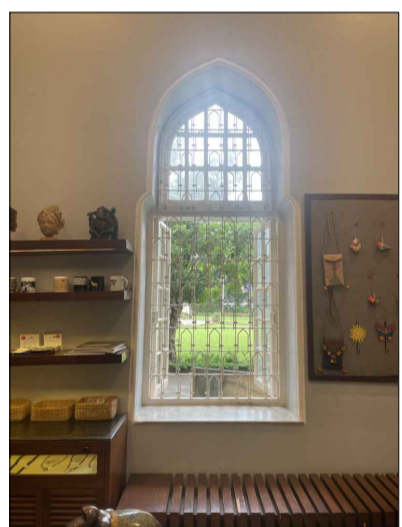


NUMBERS REQUIRED: 1  
SCREEN TRANSMITTANCE: 30%

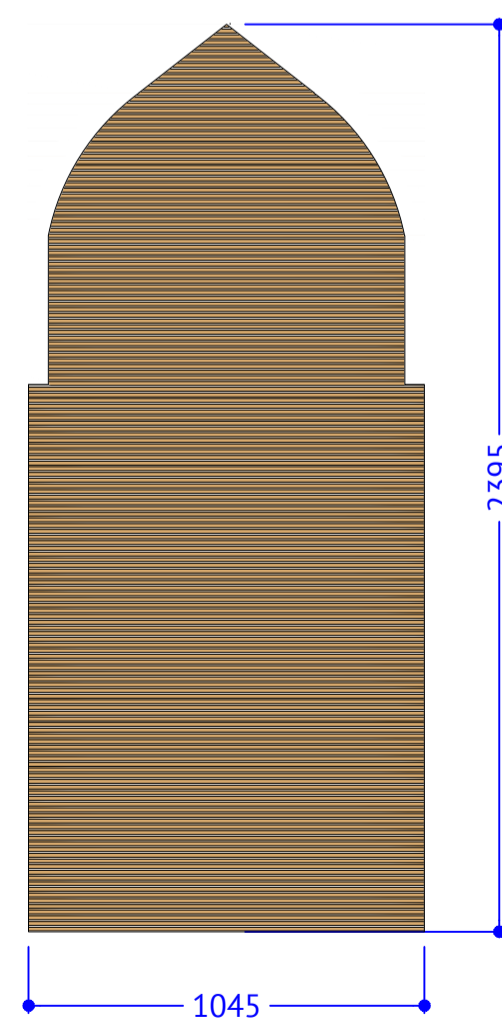

 
4 GROUND FLOOR SHOP WINDOW ELEVATION  
1:20

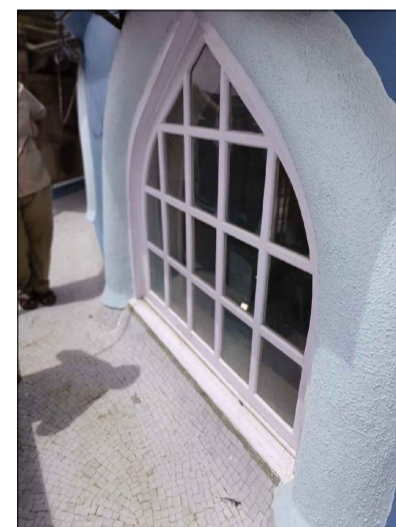

NUMBERS REQUIRED: 8  
SCREEN TRANSMITTANCE: 70%

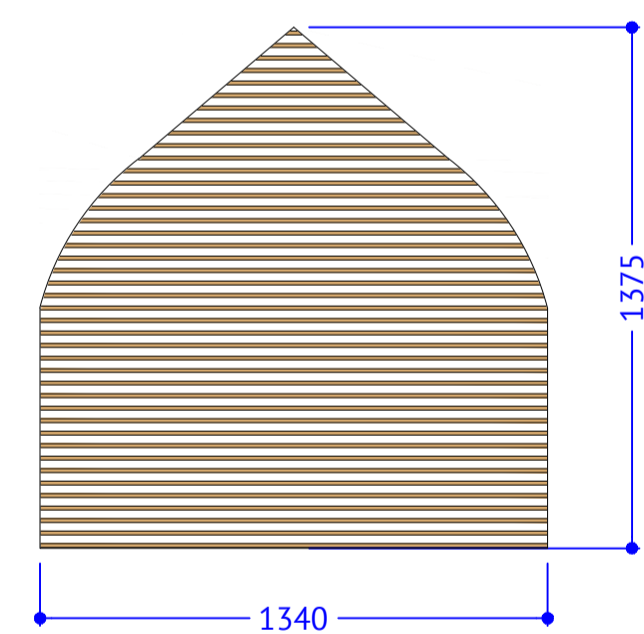


5 DOME NORTH WINDOW ELEVATION  
1:20

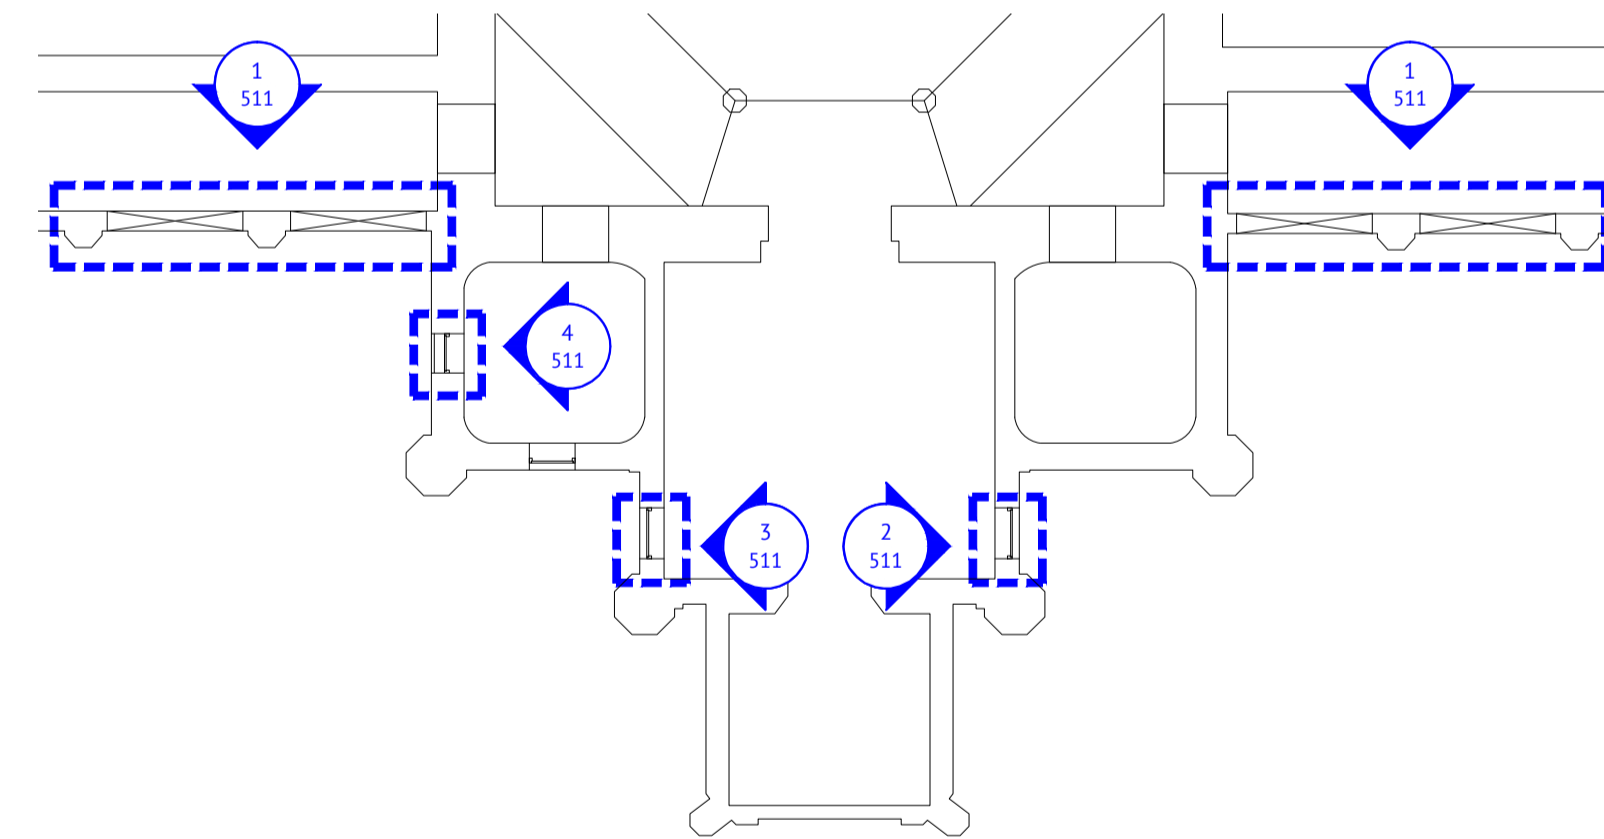


7 GROUND FLOOR WINDOW KEY PLAN  
1:200



NUMBERS REQUIRED: 8  
SCREEN TRANSMITTANCE: 30%

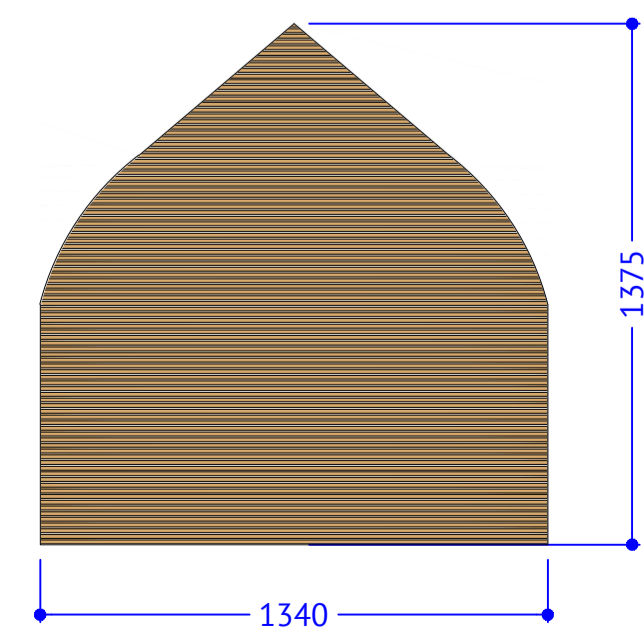



6 DOME SOUTH WINDOW ELEVATION  
1:20

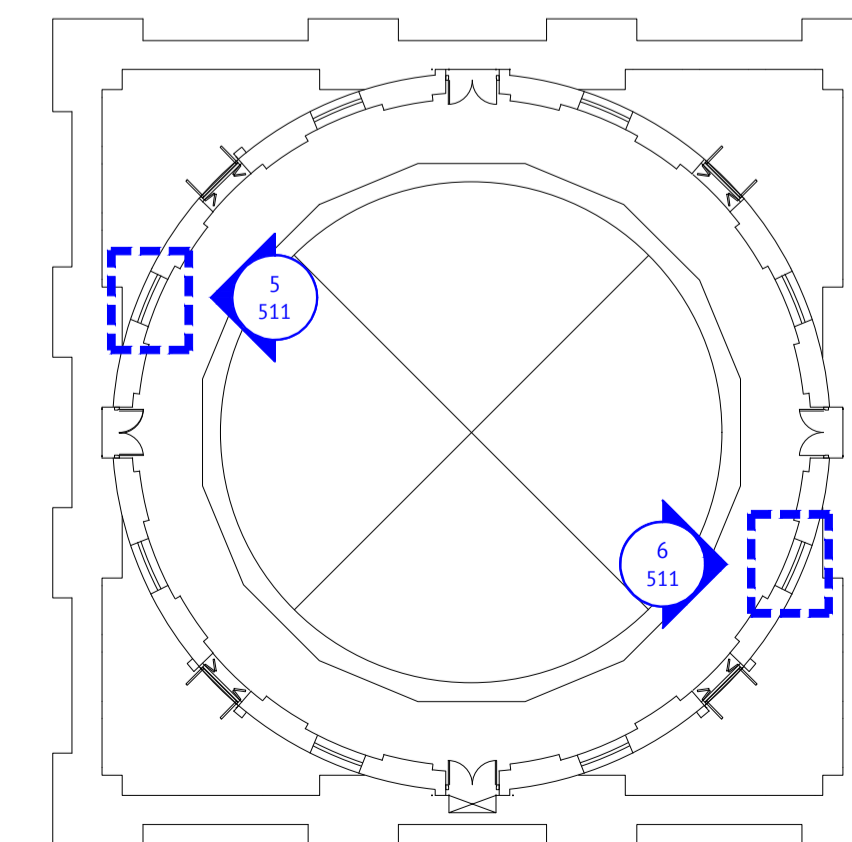

8 DOME WINDOW KEY PLAN  
1:200




LAYOUT NOTES:  
REFER TO ARCHITECTS DRAWINGS FOR FINAL LIGHTING LAYOUTS  
THIS DRAWING IS TO BE READ IN CONJUNCTION WITH RELEVANT LIGHTING DESIGN PARTNERSHIP DETAIL DRAWINGS, LDP LUMINAIRE AND LIGHTING CONTROL SPECIFICATION AND VERIFIED AGAINST ARCHITECTURAL AND ELECTRICAL ENGINEERING DRAWINGS  
THIS DRAWING IS INDICATIVE ONLY. REFER TO ARCHITECTURAL DRAWINGS FOR FINAL AREAS, LIGHTING LAYOUTS AND QUANTITIES  
REFER ELECTRICAL ENGINEERING DRAWINGS AND SCHEDULES FOR CABLING, CIRCUITING, CONDUIT AND EMERGENCY LIGHTING INFORMATION  
CONTROL CHANNELS SHOWN ARE INDICATIVE OF INTENDED GROUPINGS - REFER TO ELECTRICAL ENGINEERING DRAWINGS FOR FINAL CONTROL INFORMATION

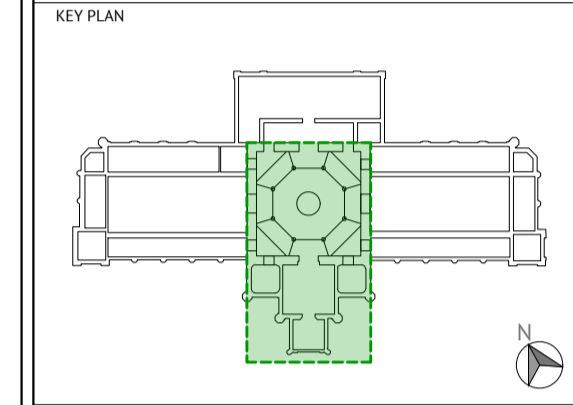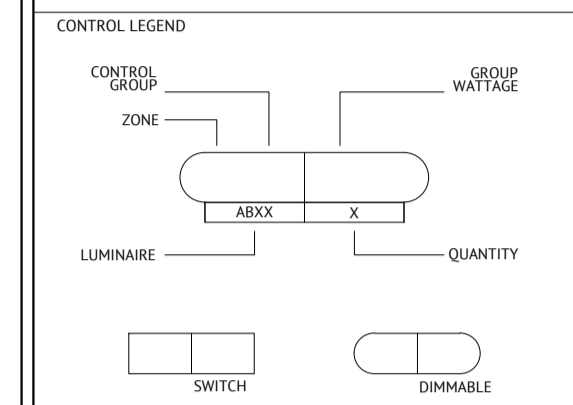

REV	NOTES	DATE
00	ORIGIN	2023-09-12

CONSULTANT

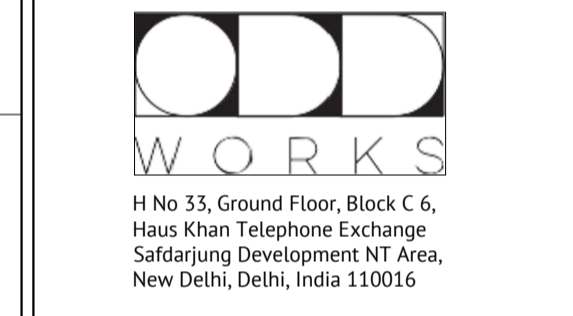

PROJECT  
AWG CSMVS, MUMBAI  
DRAWING STAGE  
DESIGN DOCUMENTATION  
DRAWING  
ELEVATION  
WINDOW

DETAILS	SHEET SIZE
LDP_2538_511.DWG PLOTTED BY OLENKA DSOUZA ON 2023-09-15	A1
REVISION	00

PROJECT & DRAWING NO  
LDP\_2538\_511  
© Lighting Design Partnership Pty Ltd

BASE DRAWING REF: