


WATER SUPPLY LAYOUT

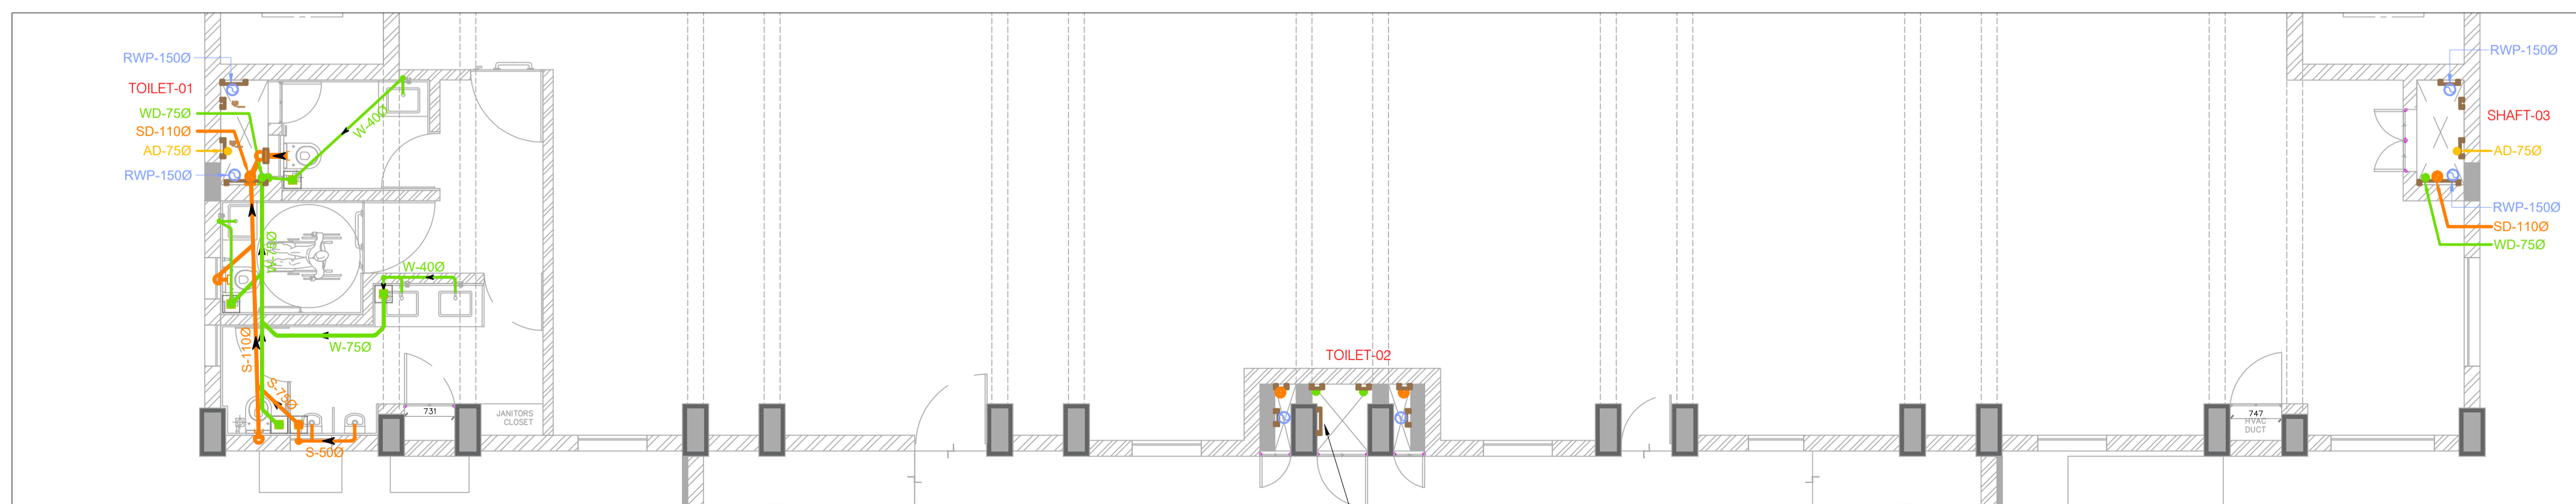

DRAINAGE LAYOUT

LEGEND	
SYMBOL	DESCRIPTION
	DOMESTIC WATER LINE
	FLUSHING WATER LINE
	HOT WATER LINE
	GEYSER
	SHOWER
	ANGLE STOCK VALVE
	SINGLE LEVER SINK MIXER
	WASH BASIN MIXER (S.L.)
	MANUAL FLUSH VALVE FOR URINAL
	SEWER LINE
	WASTE LINE
	ANTI SYPHON LINE
	RAIN WATER LINE
	FLOOR DRAIN
	SIDE WALL CLEAN OUT
	FLOOR CLEAN OUT
	INSPECTION CHAMBER (IC)
	GULLY TRAP (GT)
	WATER PURIFIER

DRAWING STATUS		APPROVAL	TENDER	EXECUTION	AS BUILT	SIGNATURE
			<input checked="" type="checkbox"/>			
A	2024-01-10	REVISED AS PER NEW ARCHITECTURAL DRG.				DS
rev	date	description				ckd.
consultants						
project		122-123, SAI COMMERCIAL CENTRE, GOVANDI STATION ROAD, DEONAR, MUMBAI - 400 088. TEL : 25507100, 25507101.				
architects		CSMVS MAX MUELLER BHAVAN, mumbai.				
title		R M A ARCHITECTS, mumbai.				
north		FIRST FLOOR LAYOUT - PHE				
drawn	SHREE	drawing no.		revision		
scale	1:75	2533 - 01 - 31		A		
date	2023-08-01					
checked	DS					

X:\BACK UP\NEW PROJECT FILES\Max Mueller Bhavan\PH & FF\CURRENT SCHEME\PH\7 2024-07-08\2024-06-22 POW MMB ALL FLOOR-PHE.dwg